


FRONT ELEVATION

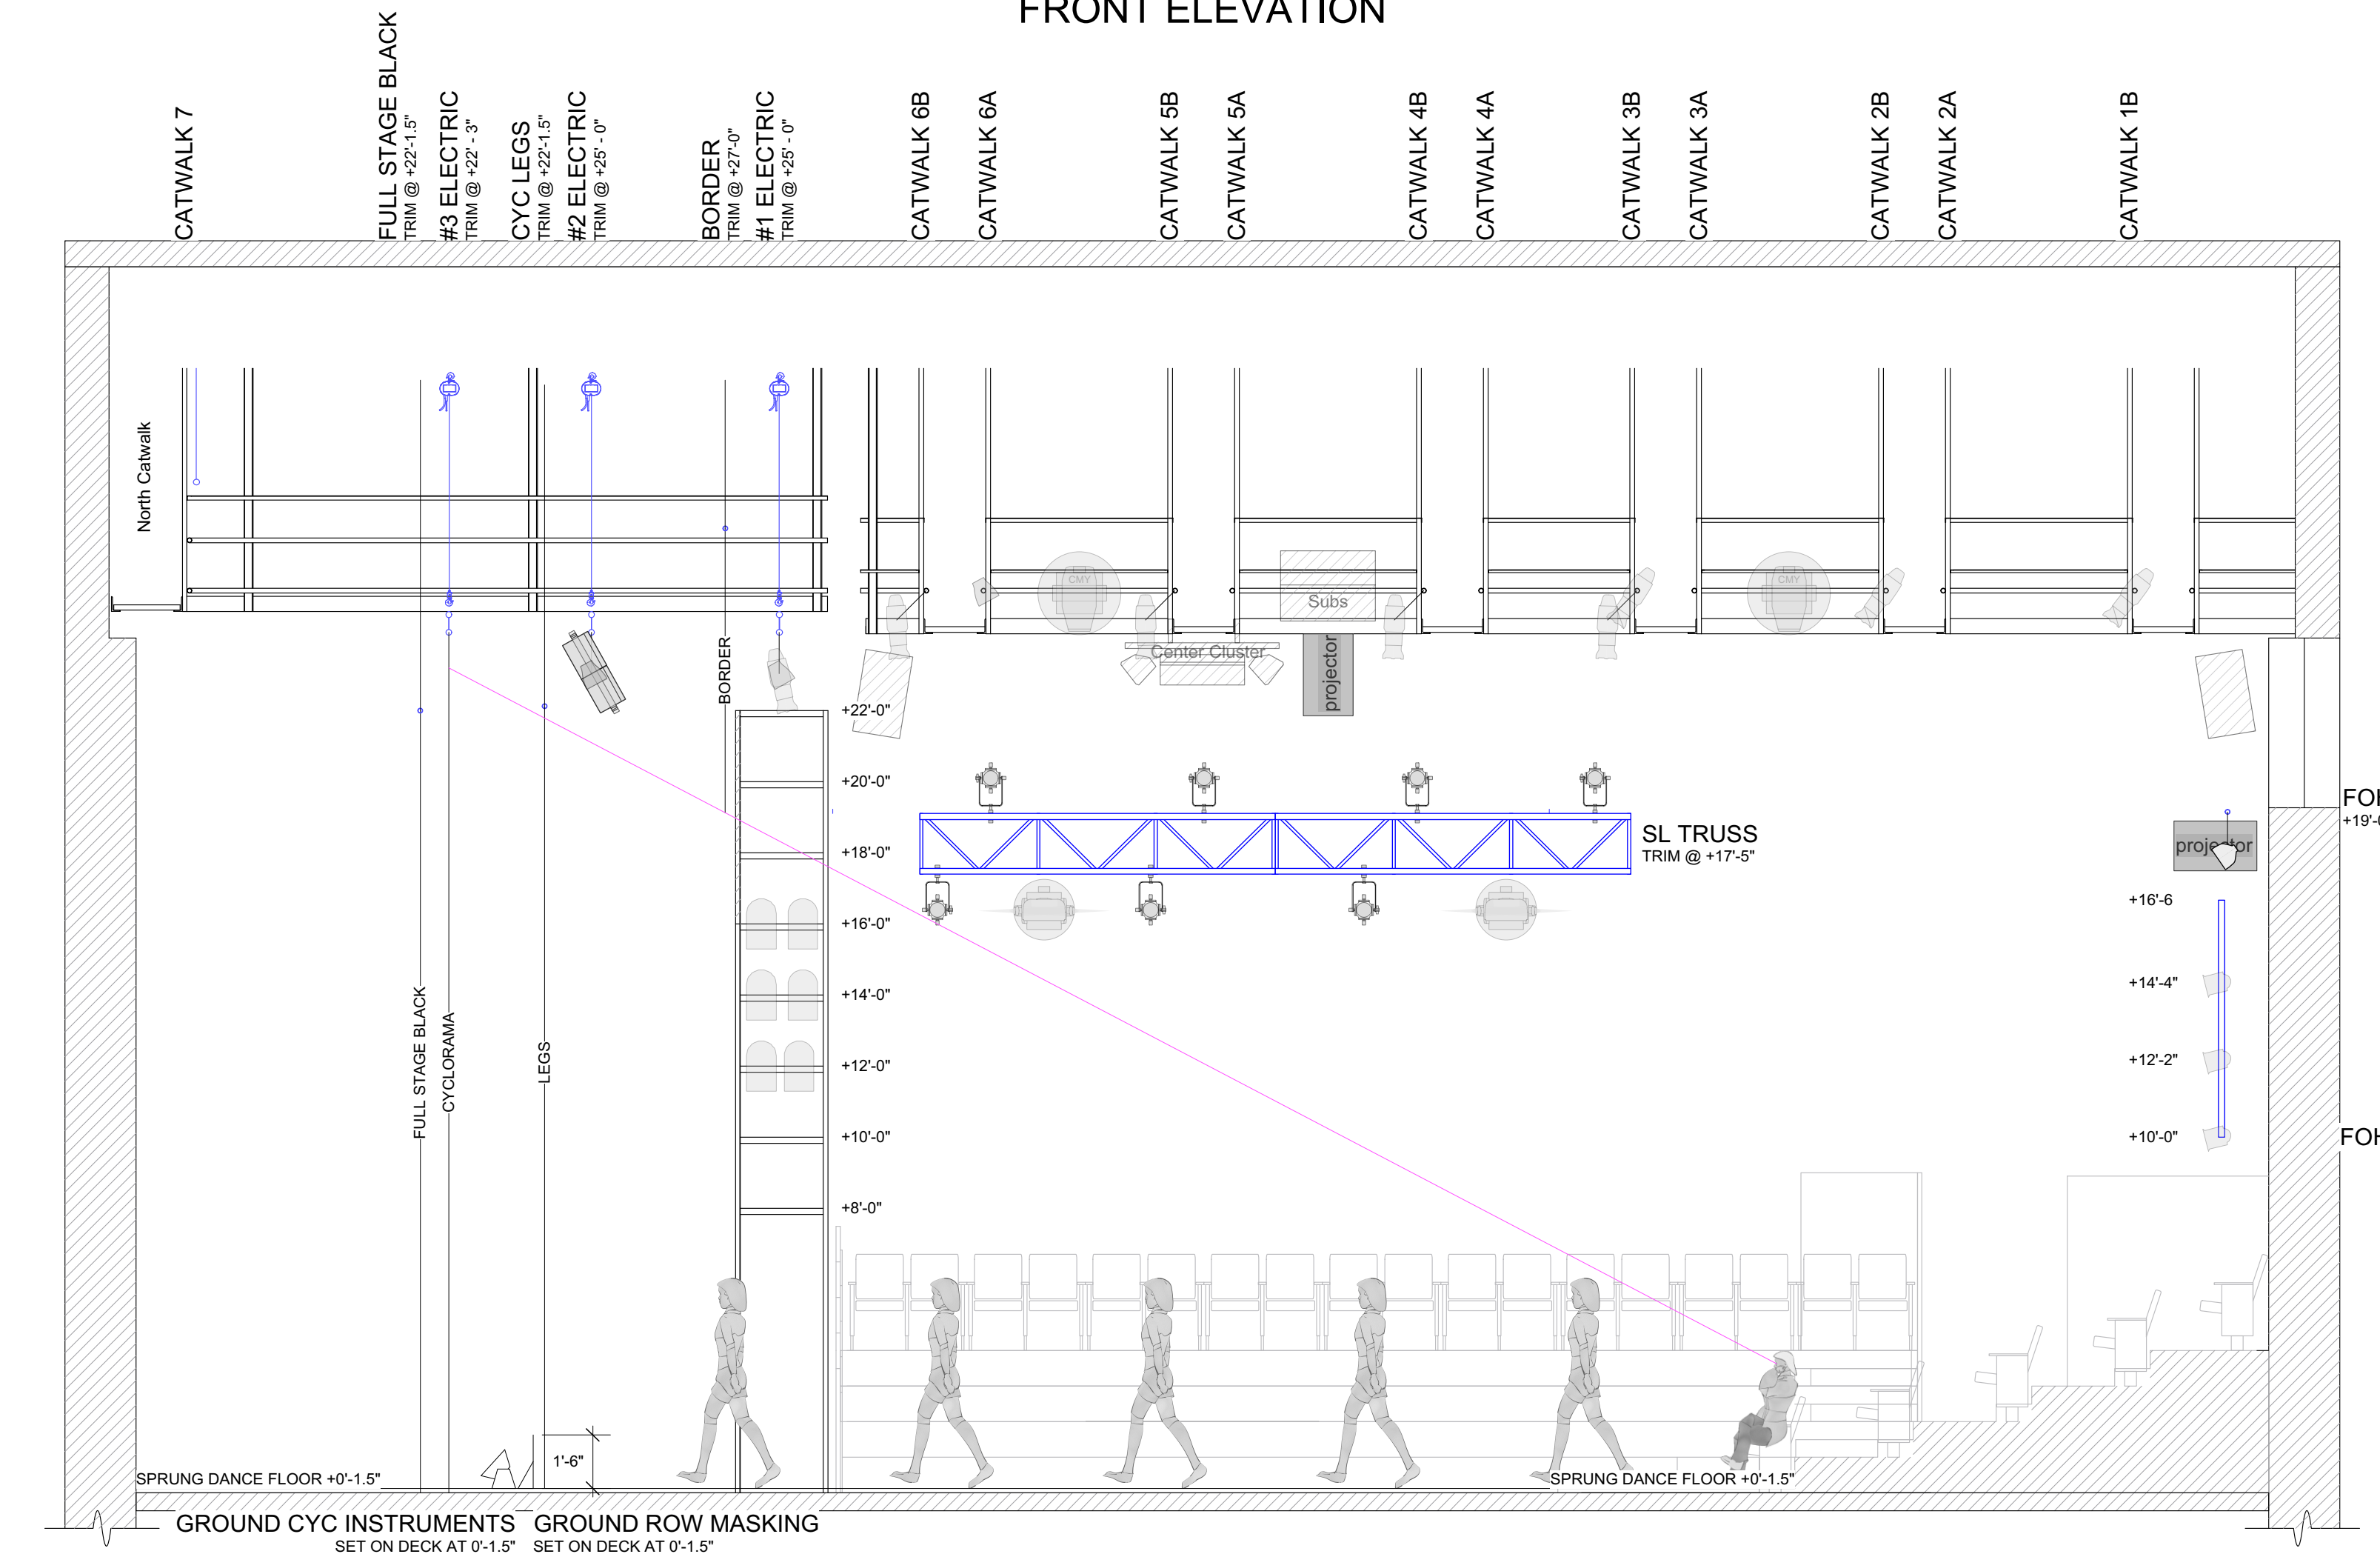

SECTION VIEW
FACING STAGE LEFT

INSTRUMENT KEY

KEY	INVENTORY
	ETC Source4 19 degree 750w 8/8
	ETC Source4 26 degree 750w 47/48
	ETC Source4 36 degree 750w 36/36
	Altman 6in Fresnel 750w 12/15
	Altman PAR 64 MFL 1000w 12/12
	ETC CE Source4 PAR MFL 570w 10/12
	ETC ColorSource PAR Medium Oval 80w 9/10
	High End Systems SpeedStar cz 360w 1/1
	High End Systems Pro CMY 440w 5/5
	High End Systems Solid Wash LED 37 550w 4/4

LABEL LEGEND KEY

	ACCESSORY
	UNIT NUMBER
	CHANNEL

NOTES

- Instruments without dimension labels are to be hung 18" apart
- Legs and borders may be hung on available pipes at the discretion of the technical director
- All trims reference the stage floor. Trims do not reference the sprung dance floor or the seating risers.
- Please leave black duvetyne truss masking in place for this production.

THE UNIVERSITY OF TEXAS AT AUSTIN
TEXAS THEATRE & DANCE
 300 E. 23RD STREET
 AUSTIN, TX 78712
 Oscar Brockett Theatre

DRT
(R)evolution

THIS DRAWING REPRESENTS VISUAL CONCEPTS AND CONSTRUCTION SUGGESTIONS ONLY. THE LIGHTING DESIGNER IS UNQUALIFIED TO DETERMINE THE ELECTRICAL OR STRUCTURAL APPROPRIATENESS OF THE DESIGN AND WILL NOT ASSUME RESPONSIBILITY FOR IMPROPER ENGINEERING, CONSTRUCTION, OR USE. ALL MATERIALS AND CONSTRUCTION MUST MEET THE MOST STRINGENT LOCAL SAFETY AND FIRE CODES.

Kendra S. Wiley
 Lighting Designer
 kendra.suzanne.wiley@gmail.com
 706-714-5590
 kendraswiley.com

SCALE:	1/4"=1'-0" PLATE
DRAWN BY:	Kendra S. Wiley
CREATED:	02-13-2020
REVISED:	03-05-2020
FILE:	DRT 03052020